

END PHASE 1 WATER
8.6 Reducer w/Temp Fire Hydrant

- SANITARY NOTES**
- PROPOSED SANITARY
 - EXISTING SANITARY
 - SANITARY MANHOLE
 - SANITARY TAP
- SEE SANITARY DETAIL SHEET FOR ADDITIONAL STANDARDS (012)
ALL TAPS SHALL BE 8" DIA. MINIMUM 2% SLOPE.



- WATER NOTES**
- FUTURE WATER
 - PROPOSED WATER
 - EXISTING WATER
 - WATER VALVE
 - TYPE III FIRE HYDRANT ASSEMBLY
 - TYPE V FIRE HYDRANT ASSEMBLY
 - TEE RESTRAINED
 - CROSS
 - WATER SERVICE TAPS
 - WATER MAIN
- SEE WATER DETAIL SHEET FOR ADDITIONAL STANDARDS (011)

LEGEND:

- ESMT LINE
- BUILDING LINE
- CONCRETE WALK
- TREE LINE
- STORM
- GRADE/ELEV

STREET & SANITARY SEWER INDEX

PS	SUMMIT RESERVE DRIVE
PS	PEBBLE RUN COURT
PS	EMERALD RUN COURT
PS	SLATE RIDGE COURT
PS	BROOKE RUN CROSSING

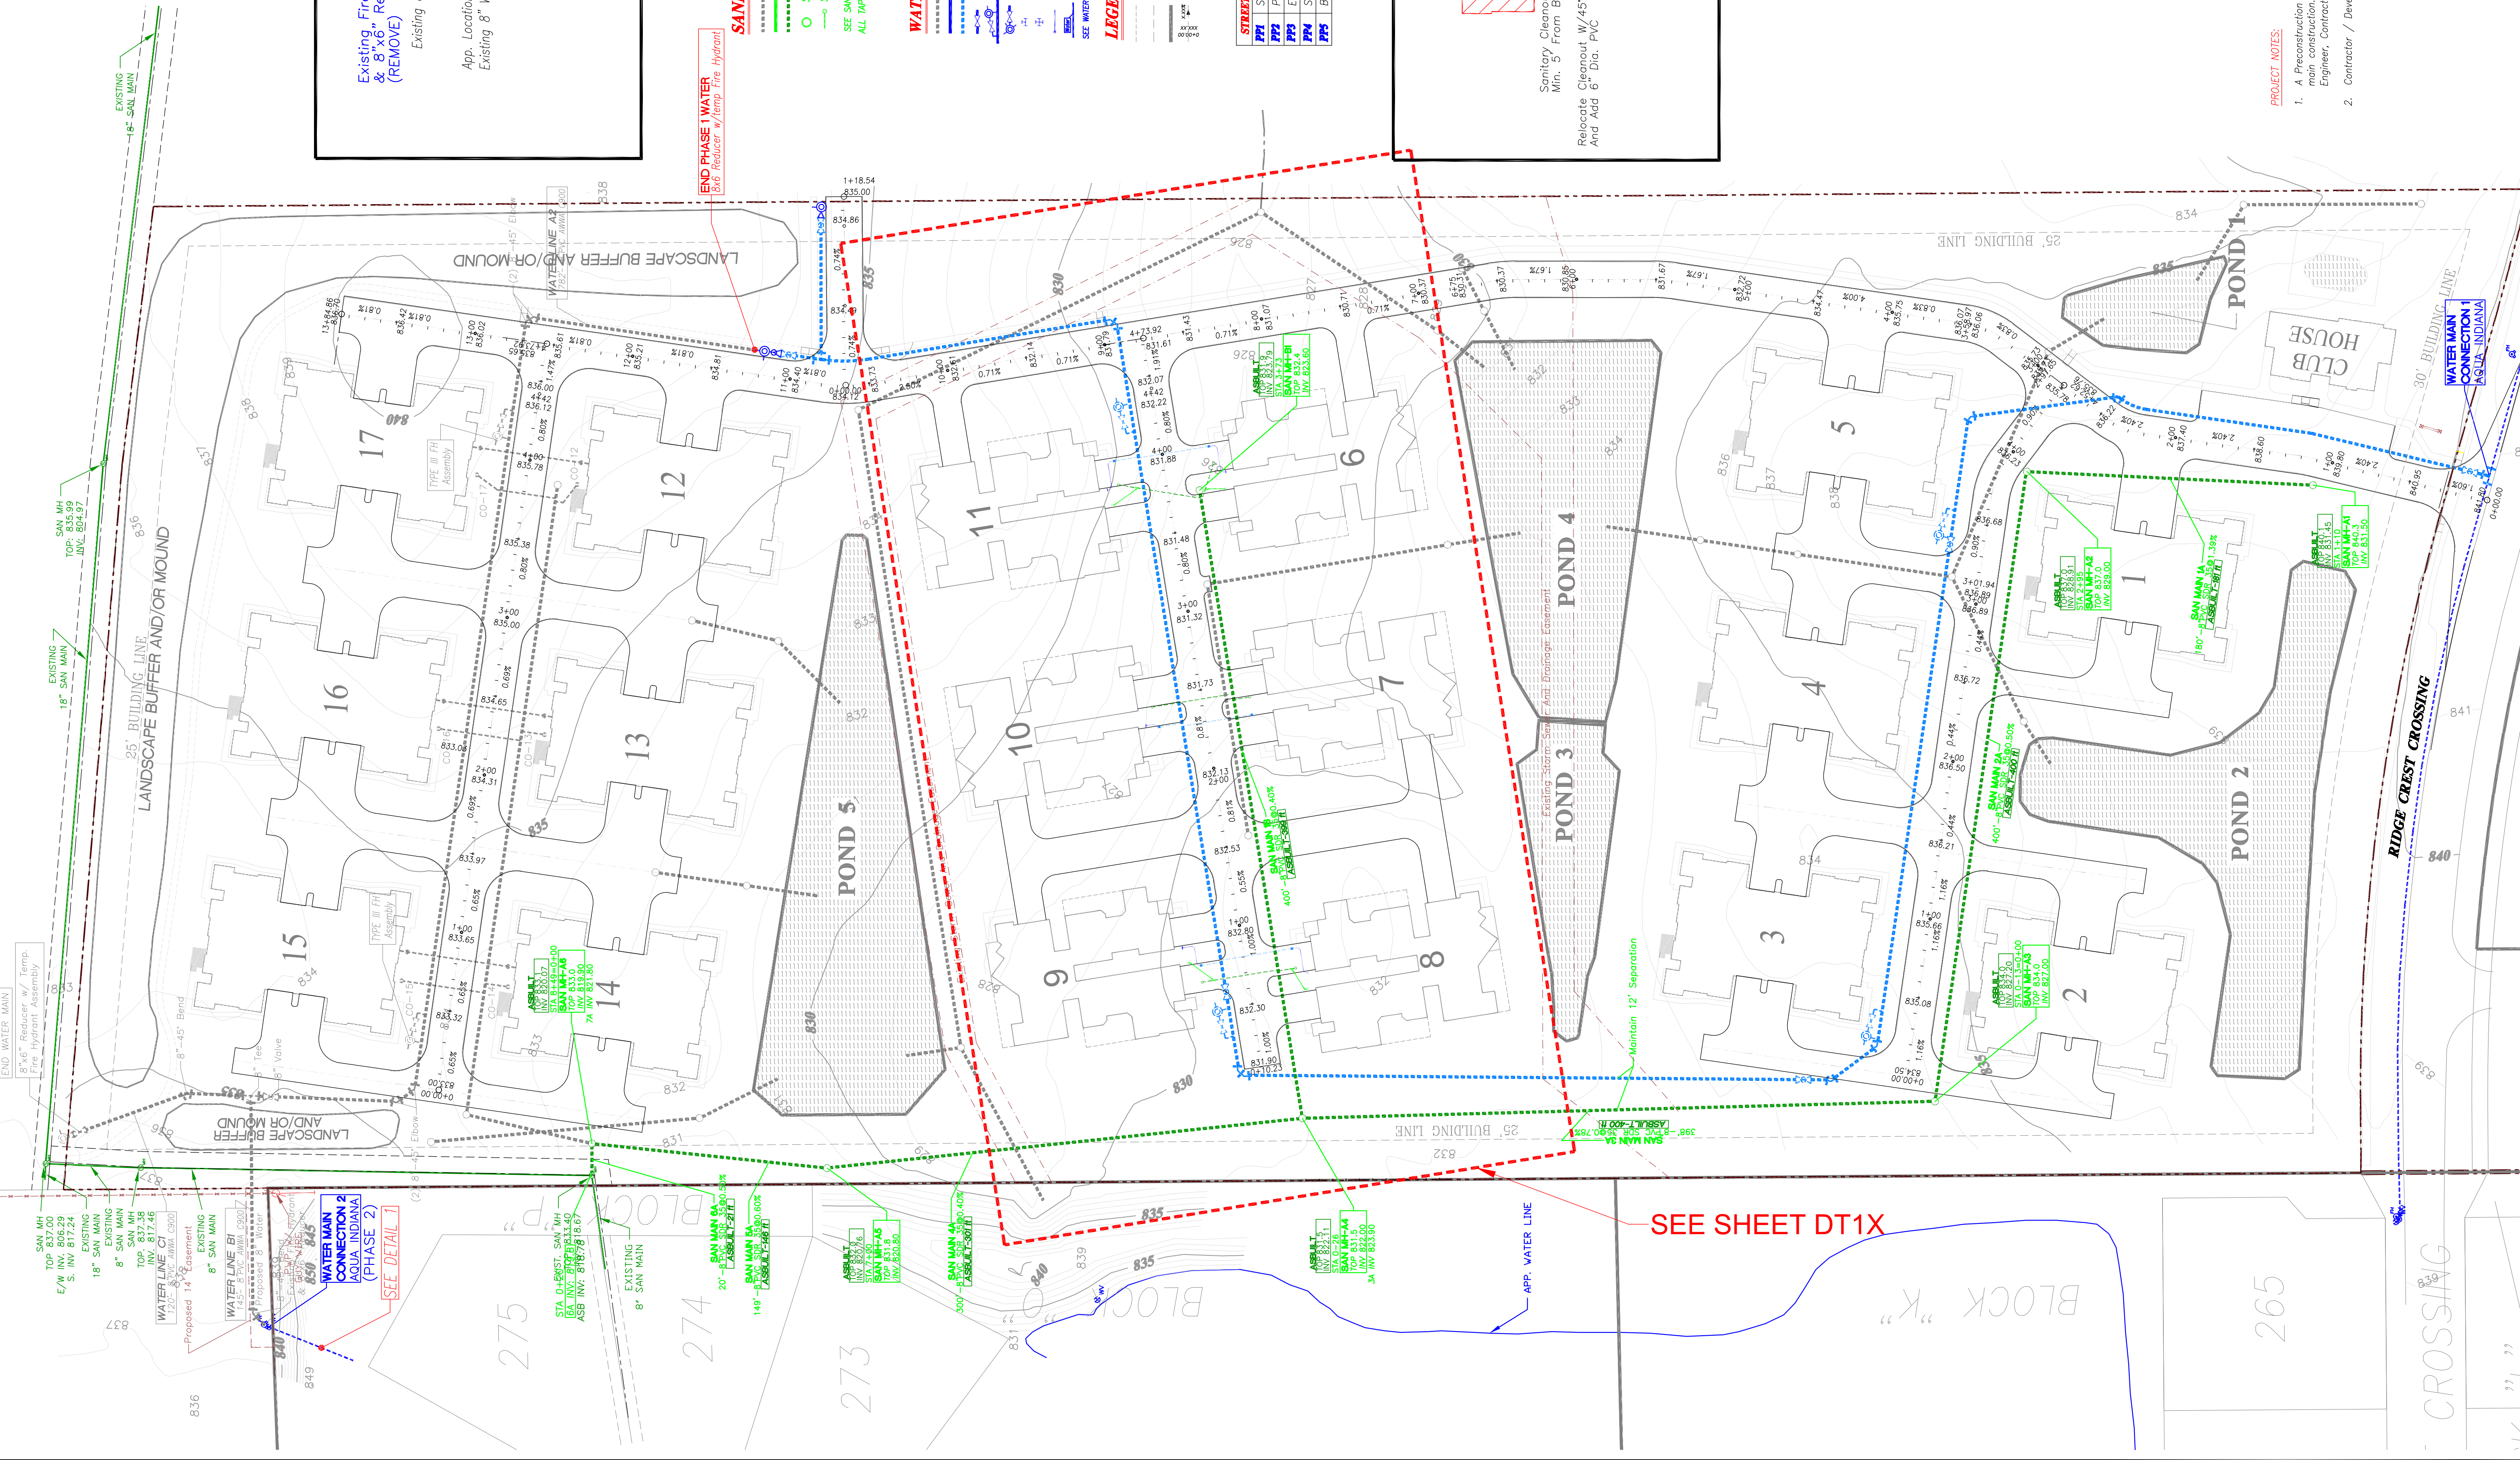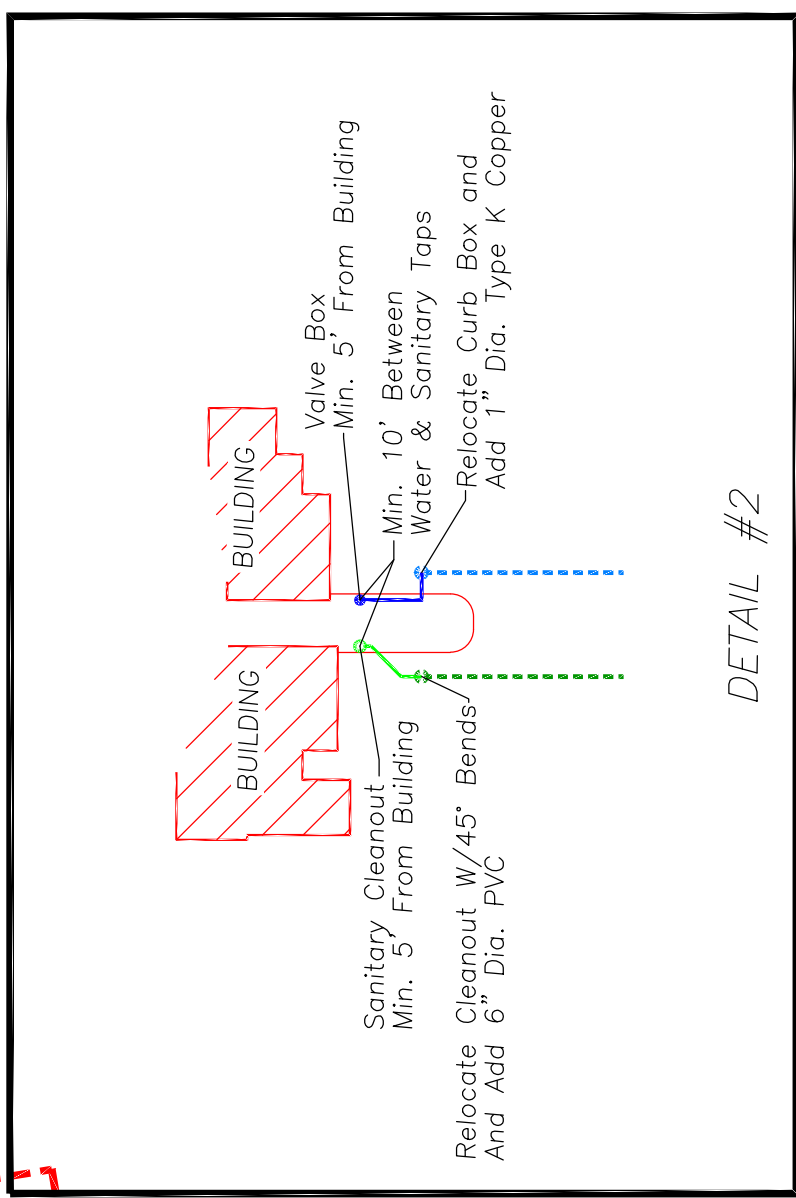

SEE SHEET DT1X

PROJECT NOTES:

- A Preconstruction Meeting is required before commencing water and sanitary work. All attendees must include Representatives from Developer, Engineer, Contractor and Aqua Indiana.
- Contractor / Developer shall install all 1" service water lines to proposed buildings.

REVISIONS

DATE	DESCRIPTION
12/20/06	Water XI, cl tap valves
3-16-07	PROPOSED STORM-TWO
3-22-07	SAN PIPE AND STRUCTURE LOCATION AND INFO- AIR
04/29/10	Buildings 6-11
05/11/10	Sanitary and Water Taps

DATE	DRAWN BY:
10-4-06	

SCALE	CHECKED BY:
AS NOTED	

JOB NO.	SHEET NO.
0607-07	UPI

VILLAS AT SUMMIT RESERVE
PHASE ONE
ALLEN COUNTY INDIANA

DABEC
D.A. Brown Engineering Consultants
549 COUNTY ROAD 427, SUITE C, ALBURN IN 46706
PHONE: (260) 925-2020 FAX: (260) 925-1212

UTILITY PLAN
WATER & SANITARY SEWER

SANITARY NOTES



- FUTURE SANITARY
 - PROPOSED SANITARY
 - EXISTING SANITARY
 - SANITARY MANHOLE
 - SANITARY TAP
- SEE SANITARY DETAIL SHEET FOR ADDITIONAL STANDARDS (D72)
ALL TAPS SHALL BE 6" DIA @ MINIMUM 2% SLOPE.

LEGEND:

- ESMT LINE
- BUILDING LINE
- CONCRETE WALK
- GRADE/ELEV
- TREE LINE
- STORM

WATER NOTES:

- FUTURE WATER
 - PROPOSED WATER
 - EXISTING WATER
 - WATER VALVE
 - TYPE II FIRE HYDRANT ASSEMBLY
 - TYPE V FIRE HYDRANT ASSEMBLY
 - ICE RESTRAINED
 - CROSS
 - WATER SERVICE TAPS
 - WATER MAIN
- SEE WATER DETAIL SHEET FOR ADDITIONAL STANDARDS (D71)

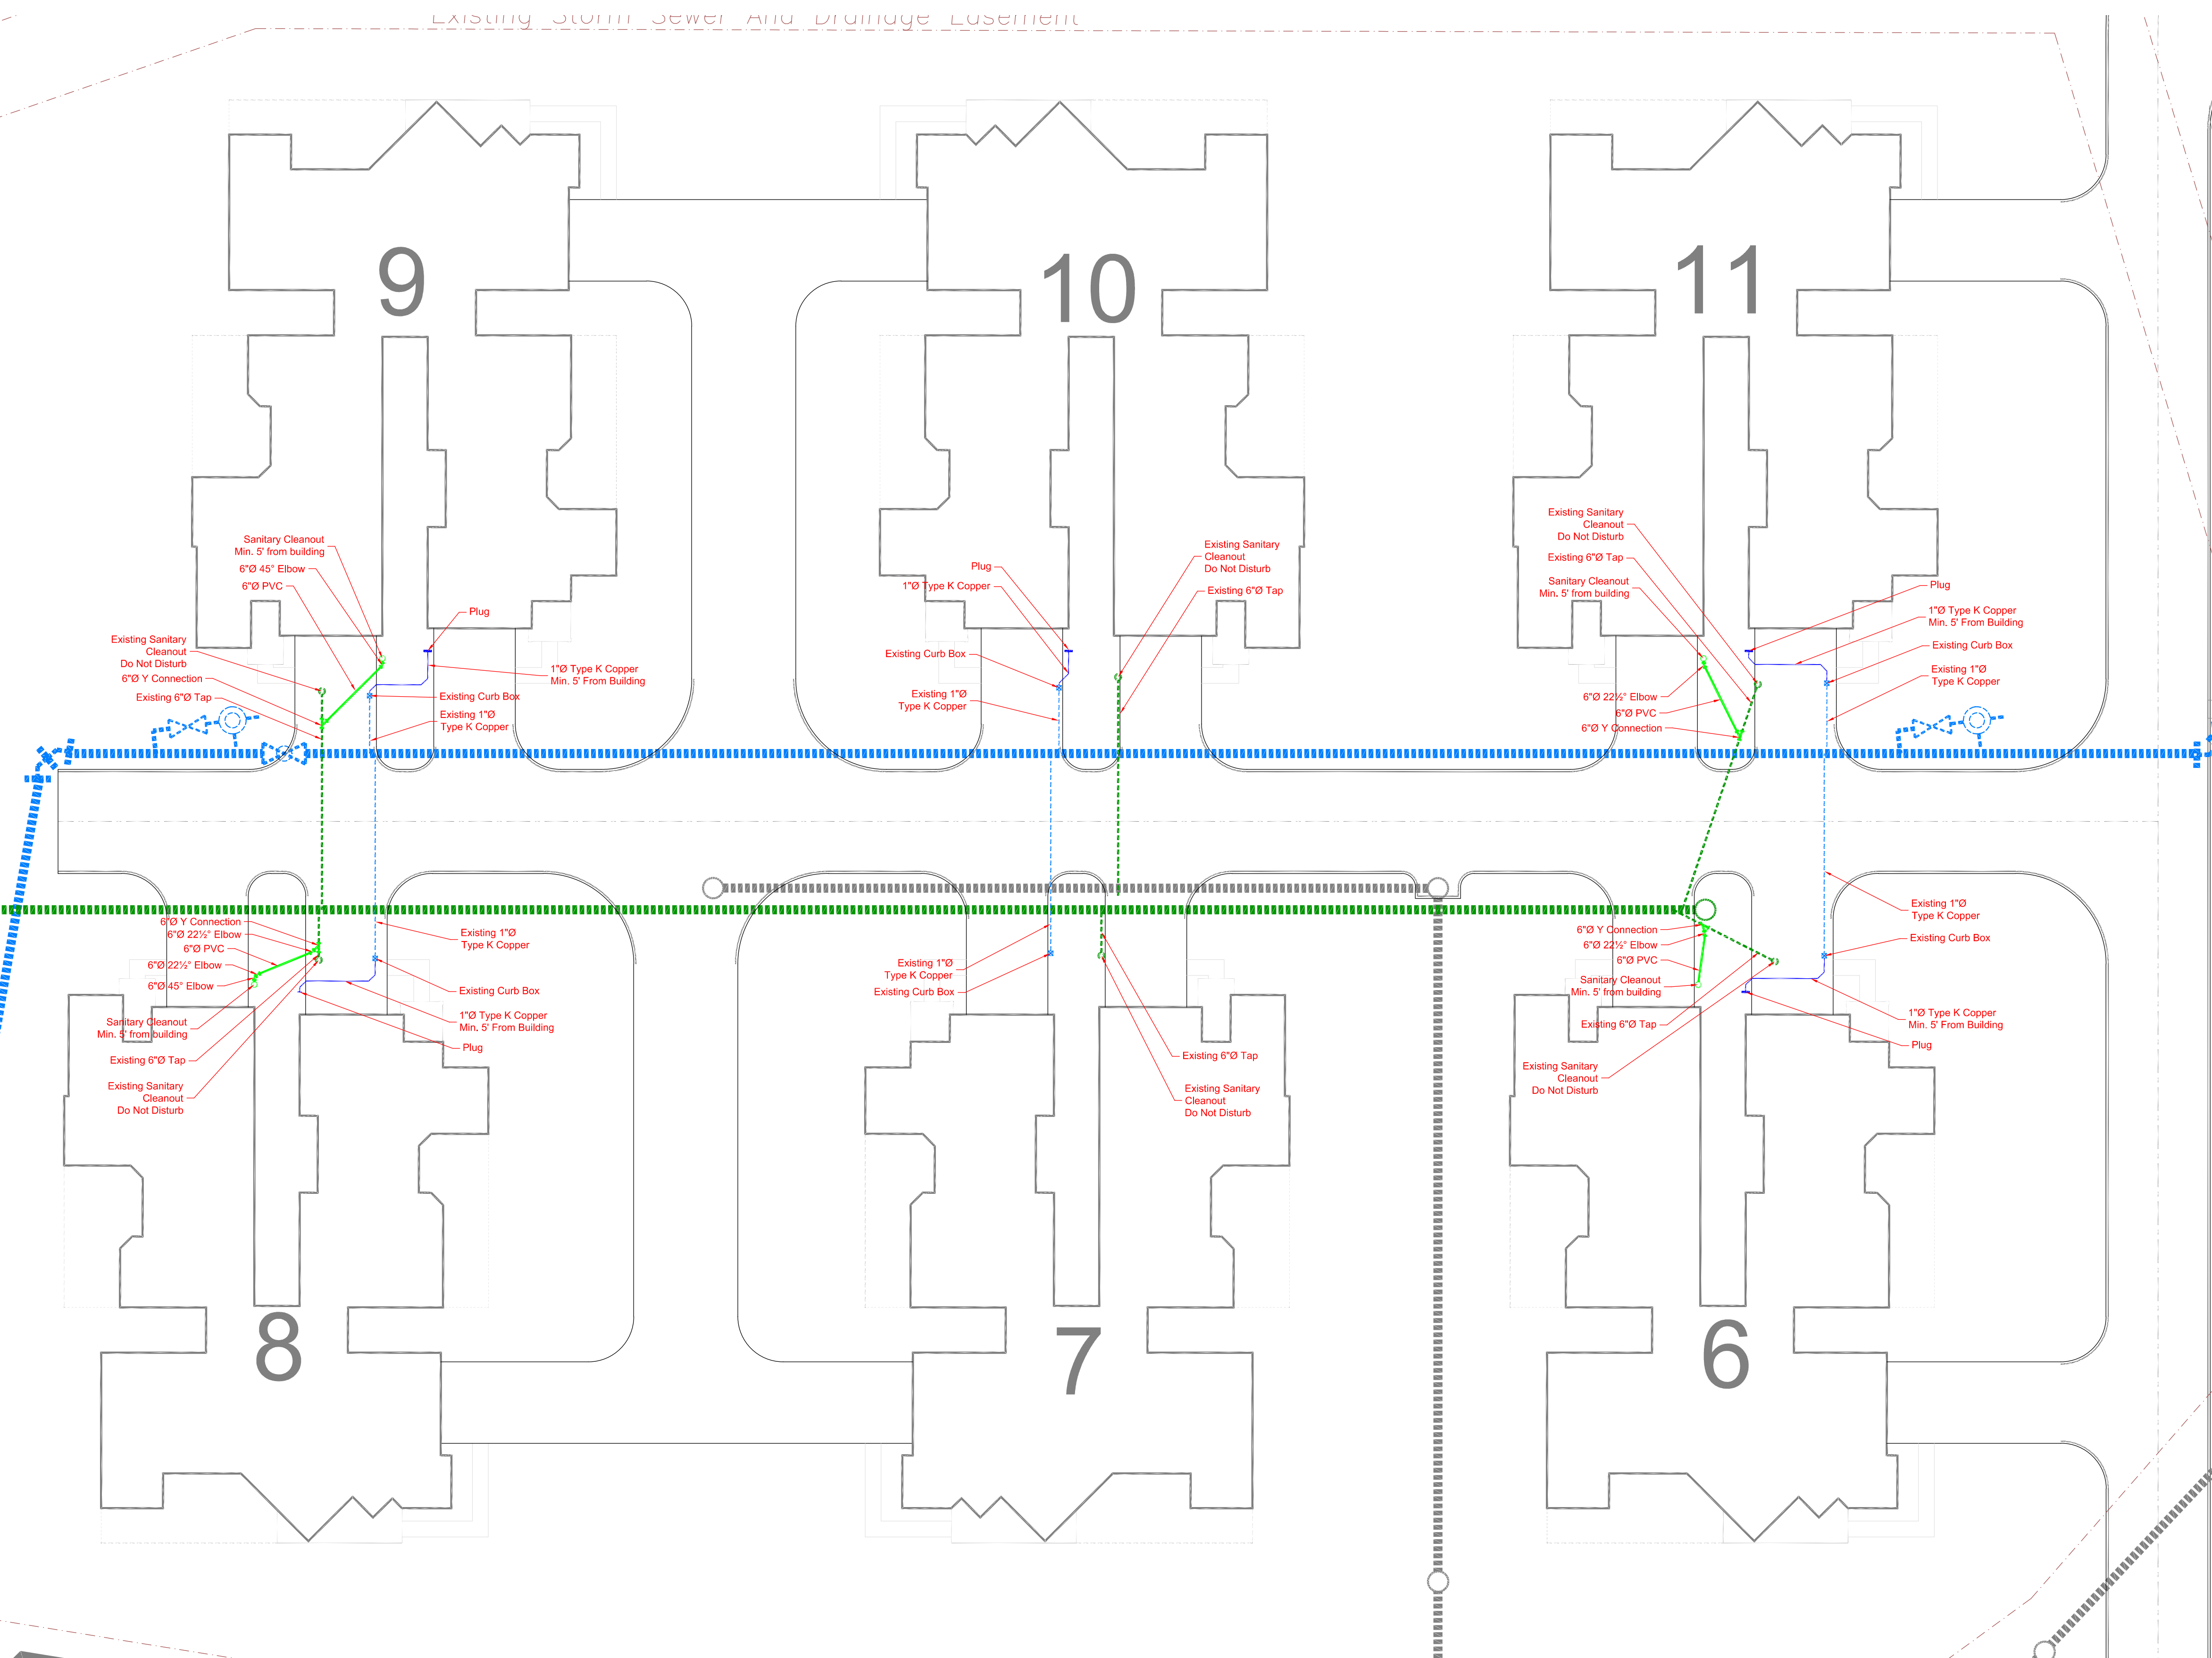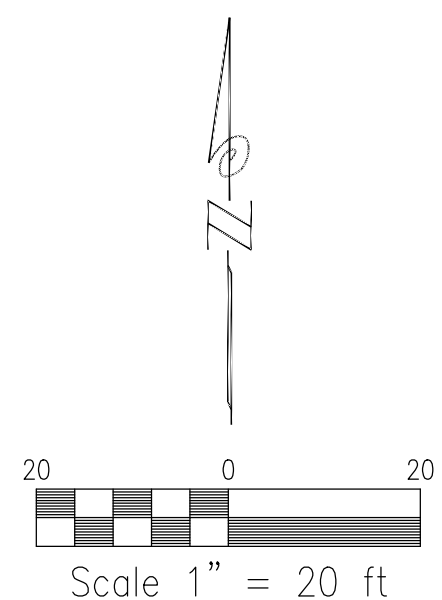

UTILITY PLAN
WATER & SANITARY SEWER

DABEC
D.A. Brown Engineering Consultants
549 COUNTY ROAD 427, SUITE C, ALBURN IN 46706
PHONE: (260) 925-2020 FAX: (260) 925-1212

VILLAS AT SUMMIT RESERVE
PHASE ONE
ALLEN COUNTY INDIANA

REVISIONS	
DATE	DESCRIPTION
12/20/06	water xl, ci tap valves
3-16-07	PROPOSED STORM-TWO
3-22-07	SAN PIPE AND STRUCTURE LOCATION AND INFO- AIR
04/29/10	Buildings 6-11
05/11/10	Sanitary and Water Taps

DATE:	DRAWN BY:
10-4-06	
SCALE:	CHECKED BY:
AS NOTED	
JOB NO.:	SHEET NO.:
0607-07	UPIX